


THIS PRINT AND ALL INFORMATION HEREON IS THE PROPERTY OF KEVIN MADSON & ASSOCIATES INC. AND SHALL NOT BE USED ON ANY OTHER JOB WITHOUT WRITTEN PERMISSION OF THE ARCHITECT
1/18/2016 12:58:24 PM 1/8" = 1'-0"

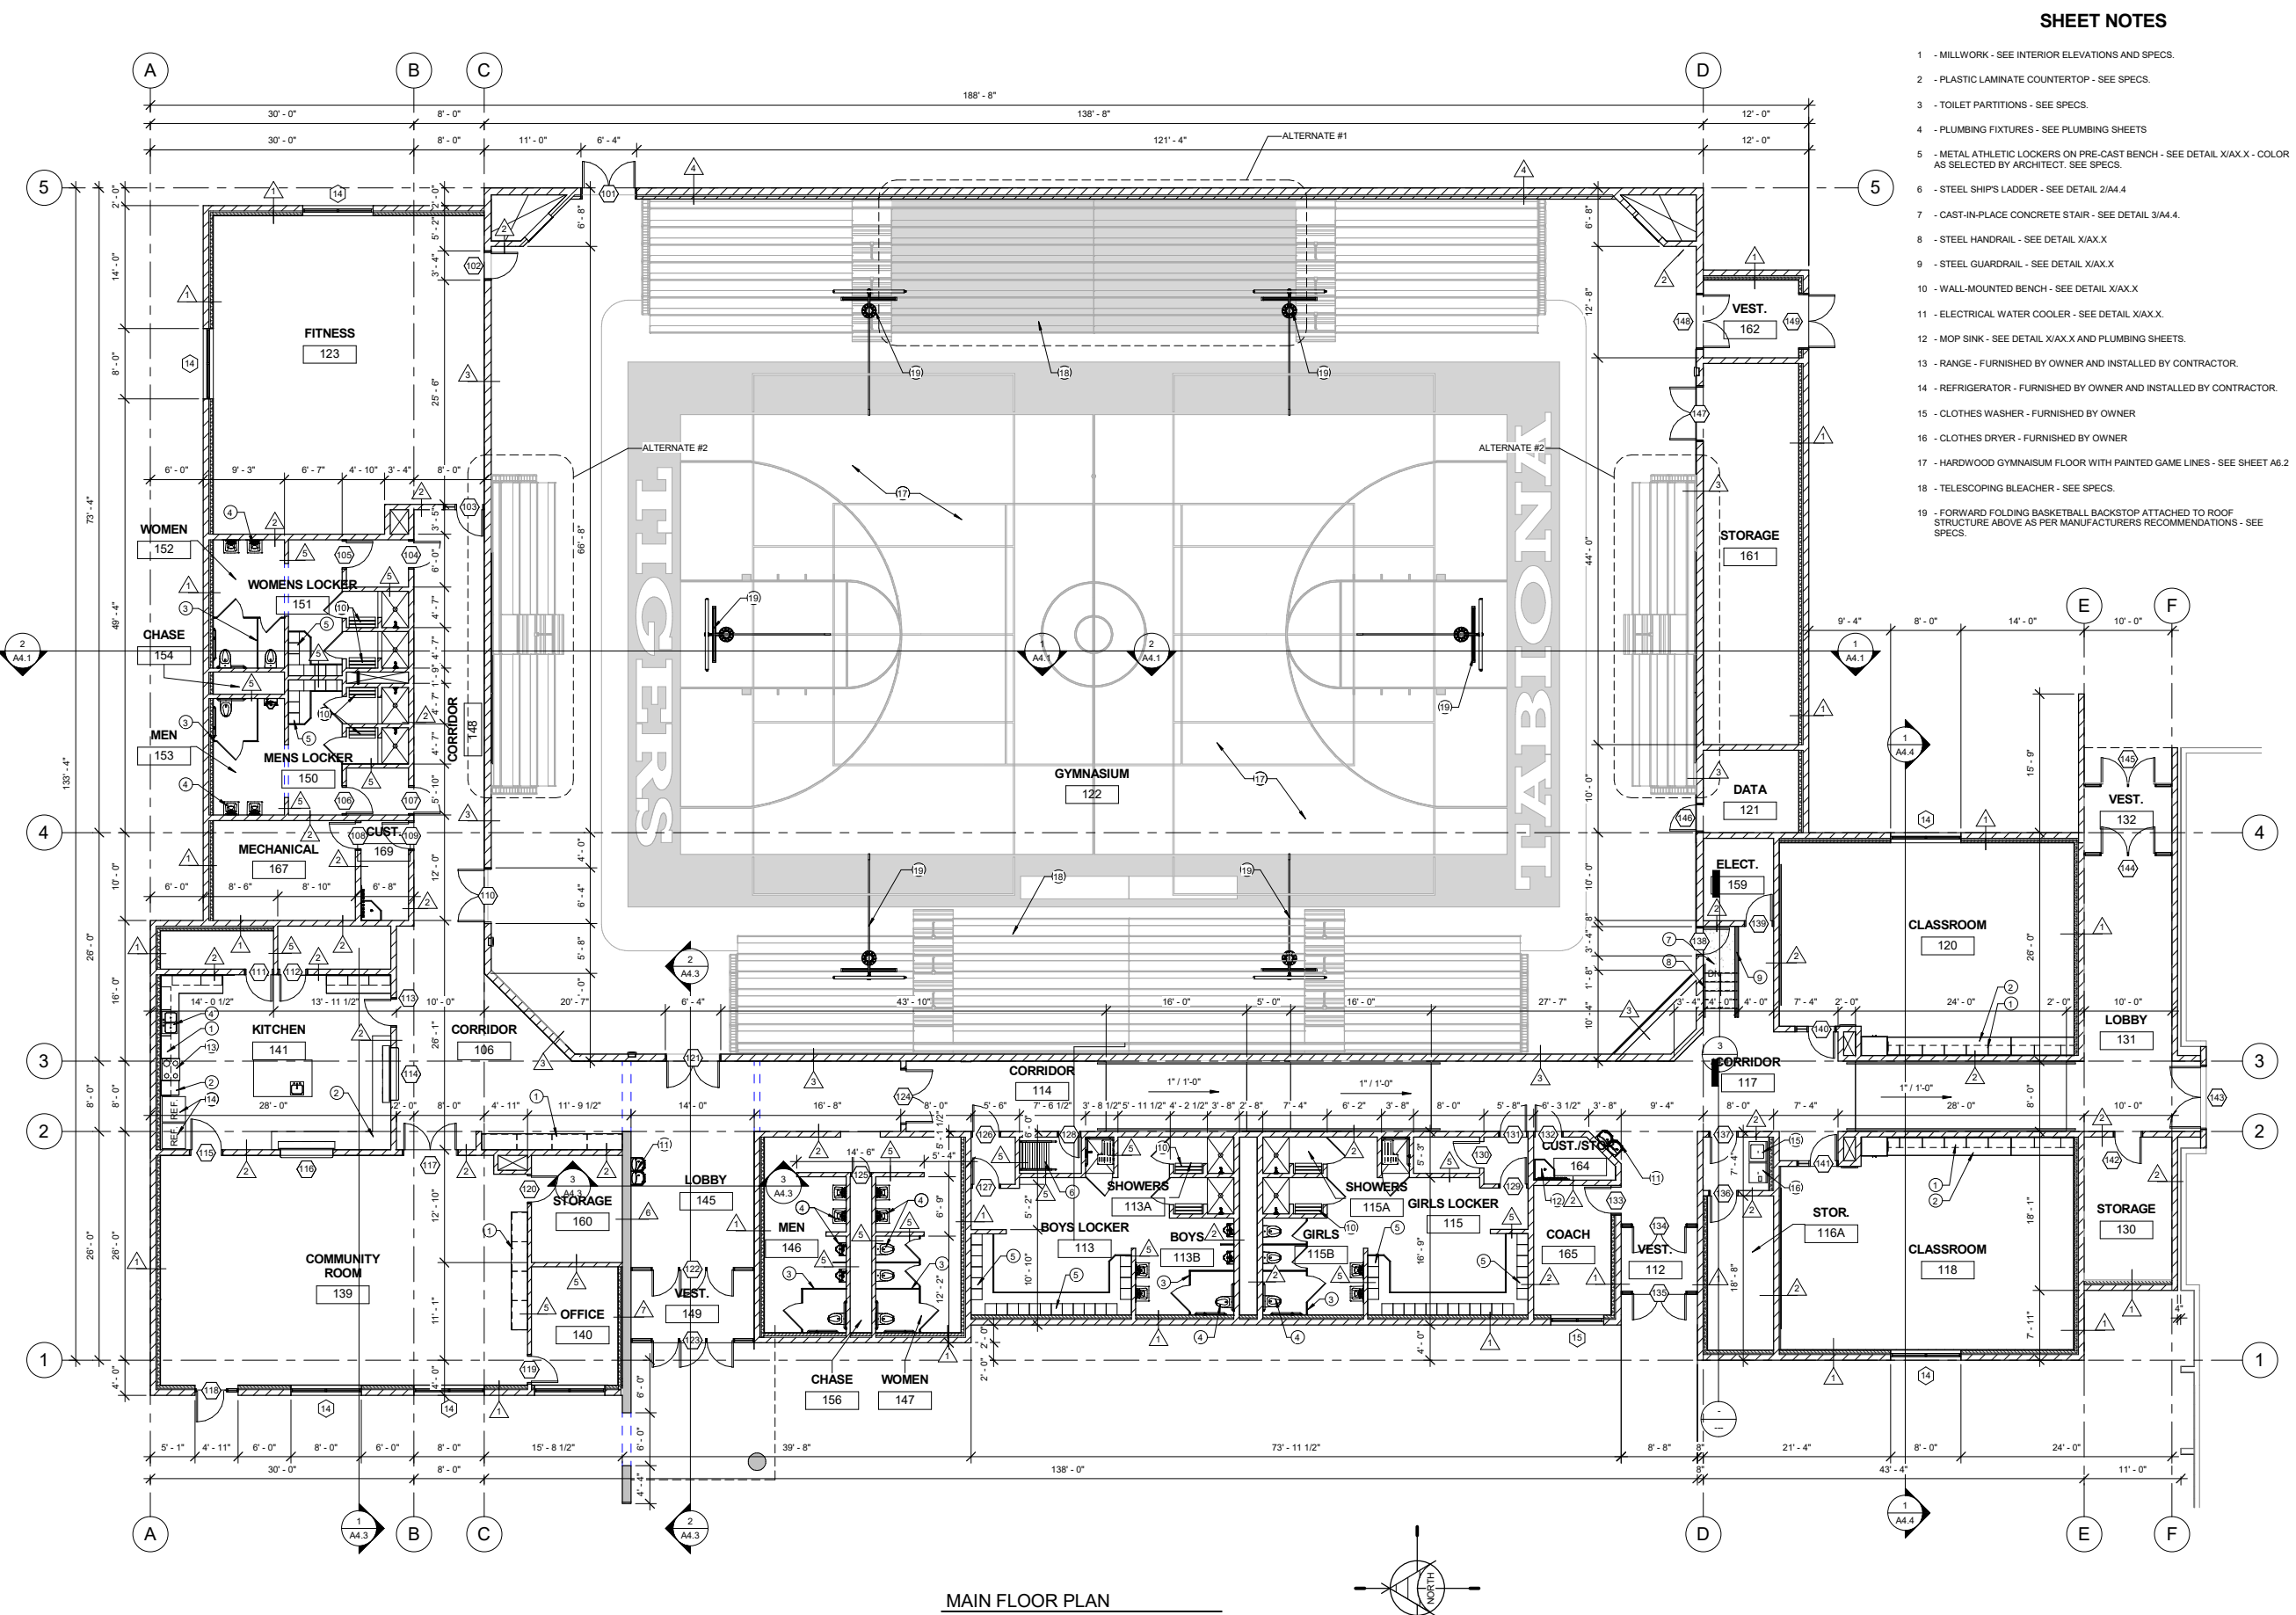

SHEET NOTES

- 1 - MILLWORK - SEE INTERIOR ELEVATIONS AND SPECS.
- 2 - PLASTIC LAMINATE COUNTERTOP - SEE SPECS.
- 3 - TOILET PARTITIONS - SEE SPECS.
- 4 - PLUMBING FIXTURES - SEE PLUMBING SHEETS
- 5 - METAL ATHLETIC LOCKERS ON PRE-CAST BENCH - SEE DETAIL X1A.X - COLOR AS SELECTED BY ARCHITECT. SEE SPECS.
- 6 - STEEL SHIP'S LADDER - SEE DETAIL 2/A4.4
- 7 - CAST-IN-PLACE CONCRETE STAIR - SEE DETAIL 3/A4.4
- 8 - STEEL HANDRAIL - SEE DETAIL X1A.X
- 9 - STEEL GUARDRAIL - SEE DETAIL X1A.X
- 10 - WALL-MOUNTED BENCH - SEE DETAIL X1A.X
- 11 - ELECTRICAL WATER COOLER - SEE DETAIL X1A.X.
- 12 - MOP SINK - SEE DETAIL X1A.X AND PLUMBING SHEETS.
- 13 - RANGE - FURNISHED BY OWNER AND INSTALLED BY CONTRACTOR.
- 14 - REFRIGERATOR - FURNISHED BY OWNER AND INSTALLED BY CONTRACTOR.
- 15 - CLOTHES WASHER - FURNISHED BY OWNER
- 16 - CLOTHES DRYER - FURNISHED BY OWNER
- 17 - HARDWOOD GYMNASIUM FLOOR WITH PAINTED GAME LINES - SEE SHEET A6.2
- 18 - TELESCOPING BLEACHER - SEE SPECS.
- 19 - FORWARD FOLDING BASKETBALL BACKSTOP ATTACHED TO ROOF STRUCTURE ABOVE AS PER MANUFACTURERS RECOMMENDATIONS - SEE SPECS.



KMA ARCHITECTS
 KEVIN MADSON & ASSOCIATES
 ARCHITECTURE & PLANNING
 195 EAST 100 NORTH PROVO, UTAH 84606
 PHONE: (801) 377-5962
 KMAARCHITECTS.COM



NO.	REVISIONS
1	ISSUED FOR PERMIT
2	REVISED
3	REVISED
4	REVISED
5	REVISED

PROJECT TITLE
TABIONA CITY
TABIONA COMMUNITY CENTER
 TABIONA, UT

DRAWN BY: Author
 CHECKED BY: Checker
 DATE: Issue Date
 PROJECT #:

A1.1

MAIN FLOOR PLAN
 1/8" = 1'-0"

